

Received Planning 9/26/22@2:13pm

Seger architects, inc
83 North Street
Salem, Massachusetts 01970
Telephone: 978-744-0208
www.segerarchitects.com

PROJECT ARCHITECT

SEAL

PROJECT CONSULTANTS

UNITED HVAC

333 Weymouth Street,
Rockland, MA

PROJECT INFORMATION

OWNER INFORMATION

No.	Description	Date


Job No.:	2020-011
Date:	September 23, 2022
Scale:	As Noted
Designed By:	DR
Drawn By:	JM
Checked By:	JAS
Approved By:	JAS
Copyright © by Seger Architects, Inc. All rights reserved.	

**Proposed
First Floor
Plan**

SHEET NAME

A-1.1

SHEET NO.

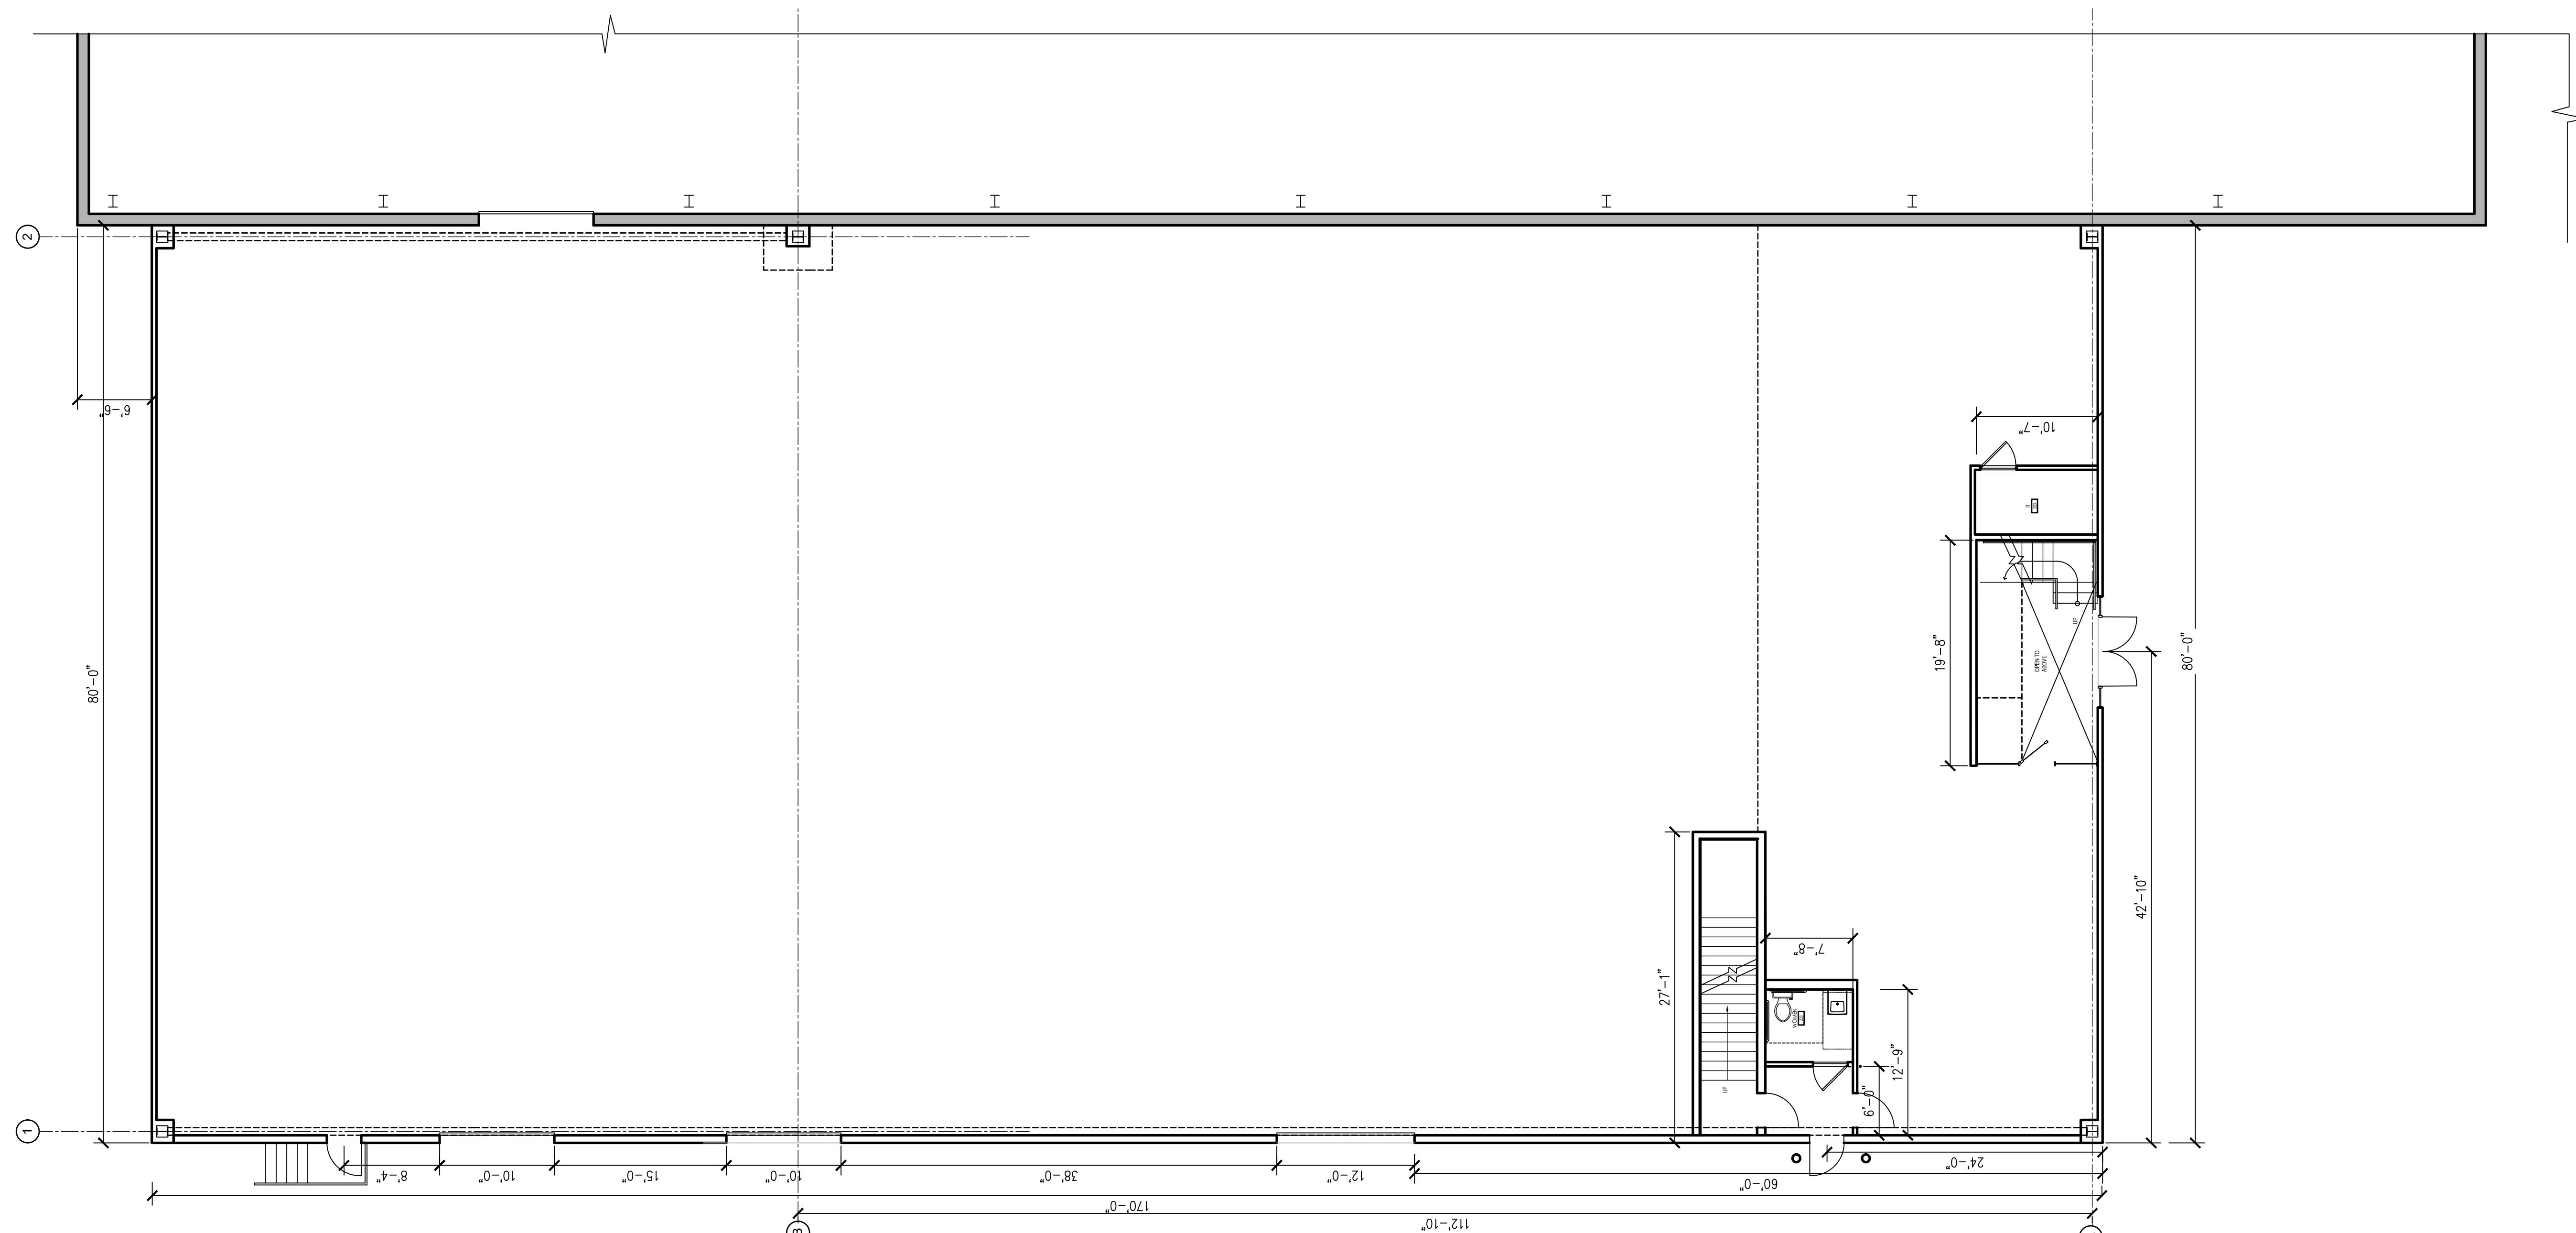

1 First Floor Plan
SCALE: 1/8" = 1'-0"

PROJECT ARCHITECT

SEAL

PROJECT CONSULTANTS

UNITED HVAC

 333 Weymouth Street,
 Rockland, MA

PROJECT INFORMATION

OWNER INFORMATION

No.	Description	Date
PROJECT REVISIONS		


Job No.:	2020-011
Date:	September 23, 2022
Scale:	As Noted
Designed By:	DR
Drawn By:	JM
Checked By:	JAS
Approved By:	JAS
Copyright © by Seger Architects, Inc. All rights reserved.	

Proposed Mezzanine Floor Plan

SHEET NAME

A-1.2

SHEET NO.

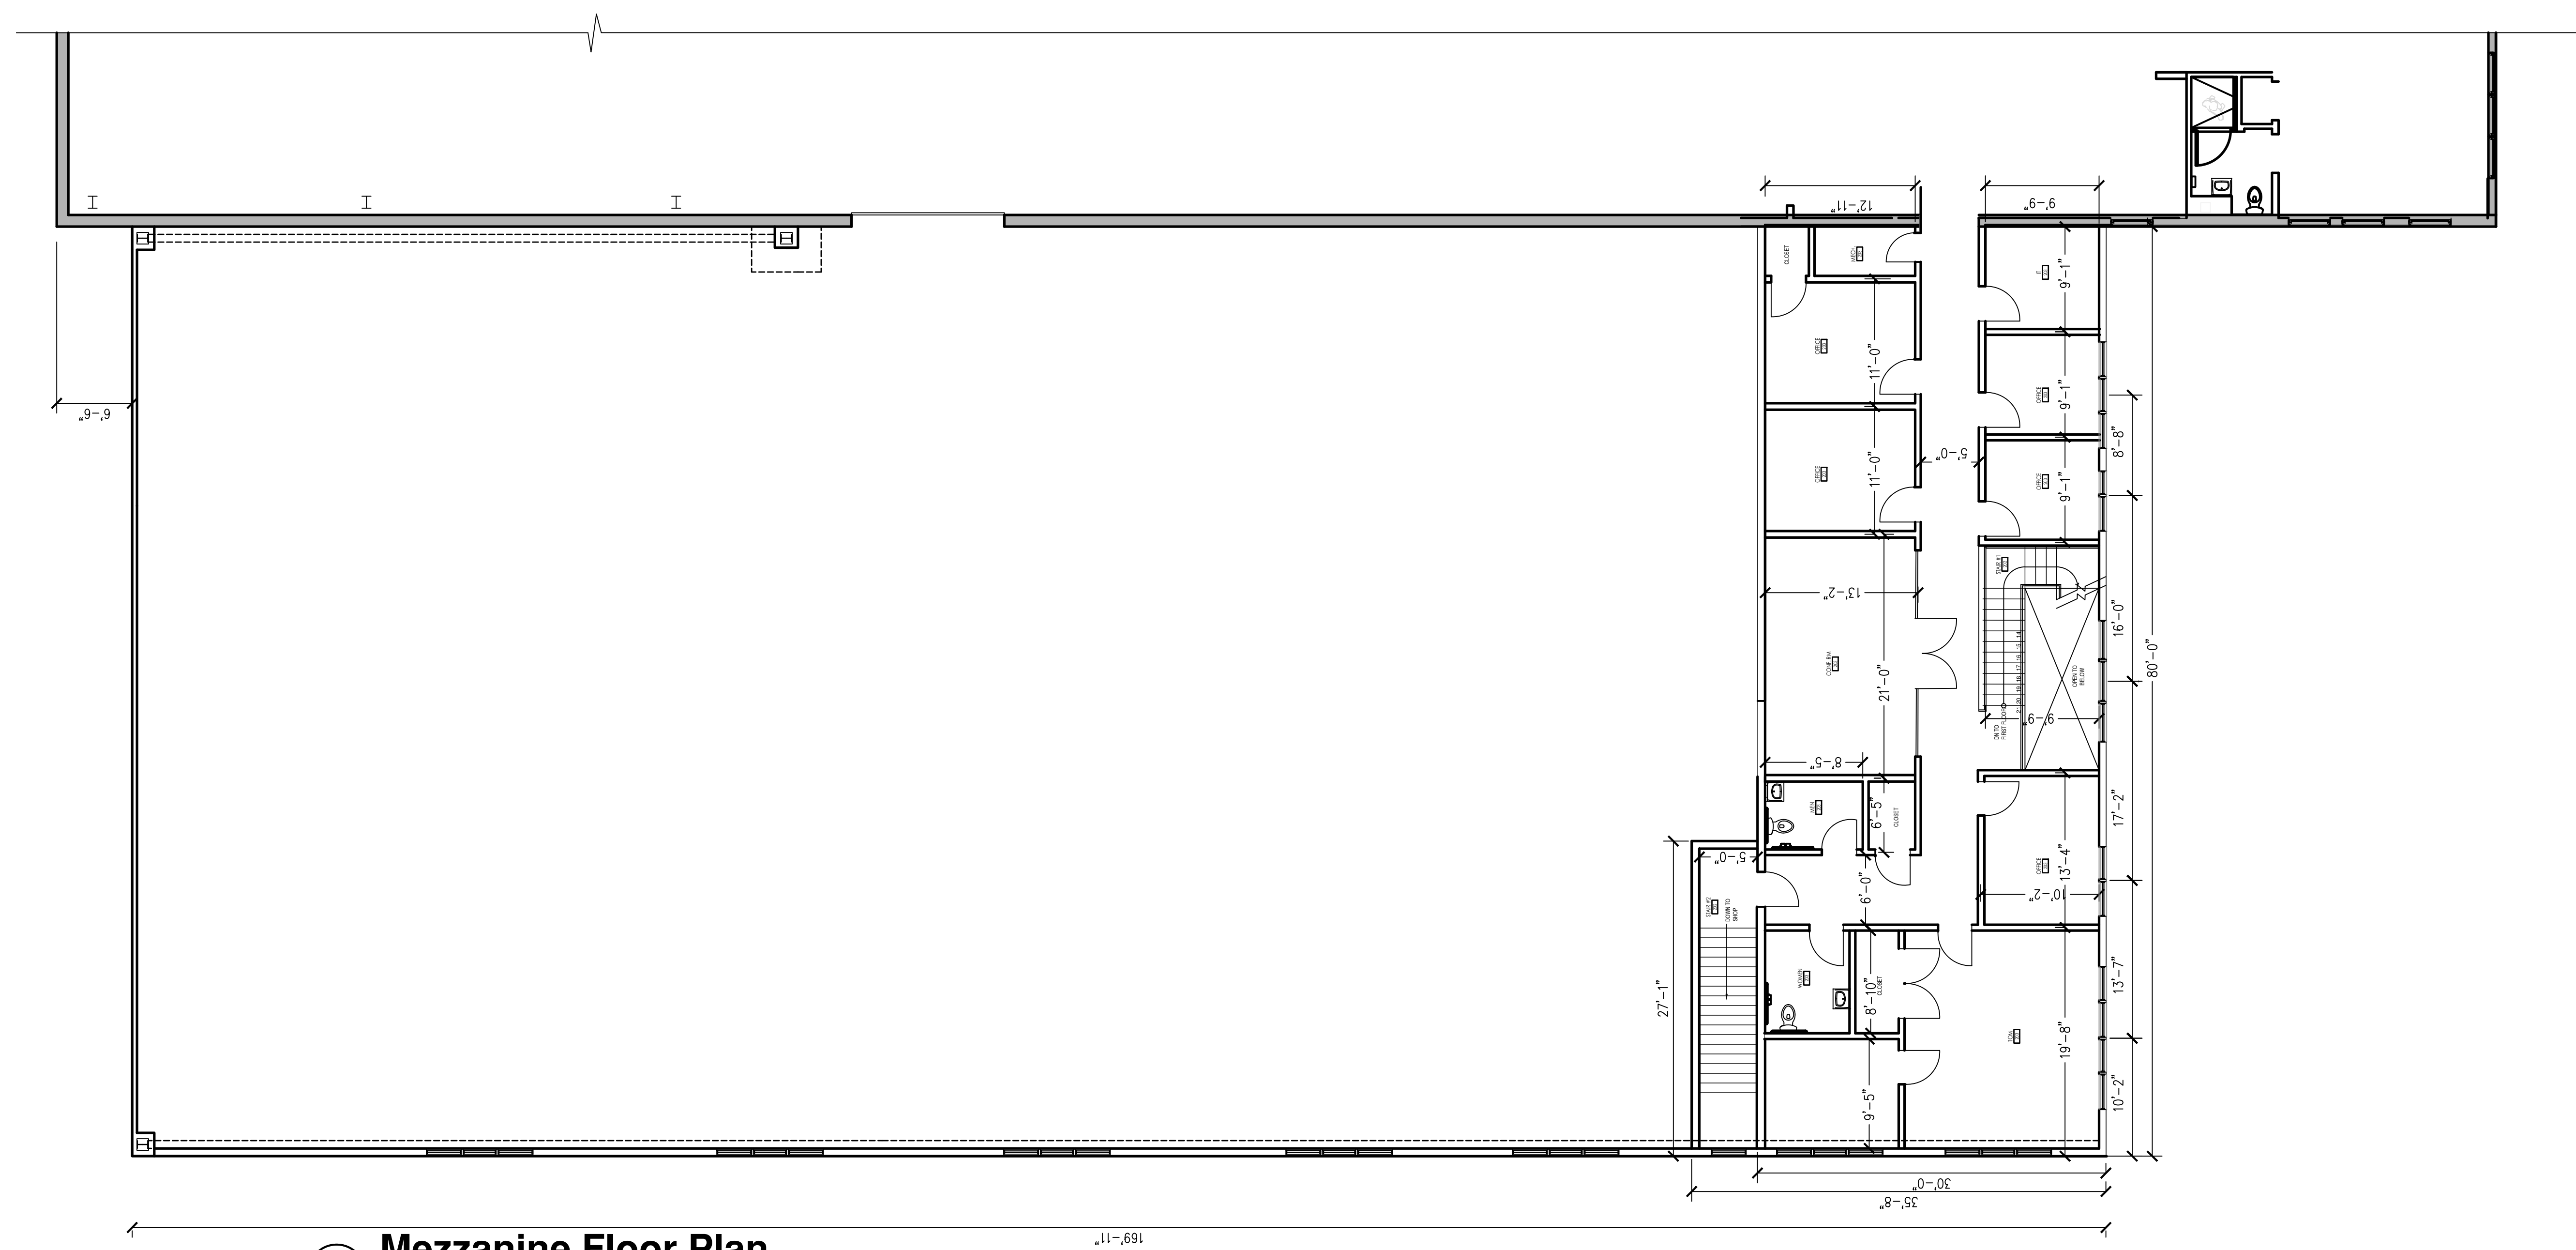


2 Mezzanine Floor Plan
 SCALE: 1/8" = 1'-0"

No.	Description	Date


PROJECT REVISIONS

Job No.:	2020-011
Date:	September 23, 2022
Scale:	As Noted
Designed By:	DR
Drawn By:	JM
Checked By:	JAS
Approved By:	JAS


Copyright © by Seger Architects, Inc.
 All rights reserved.

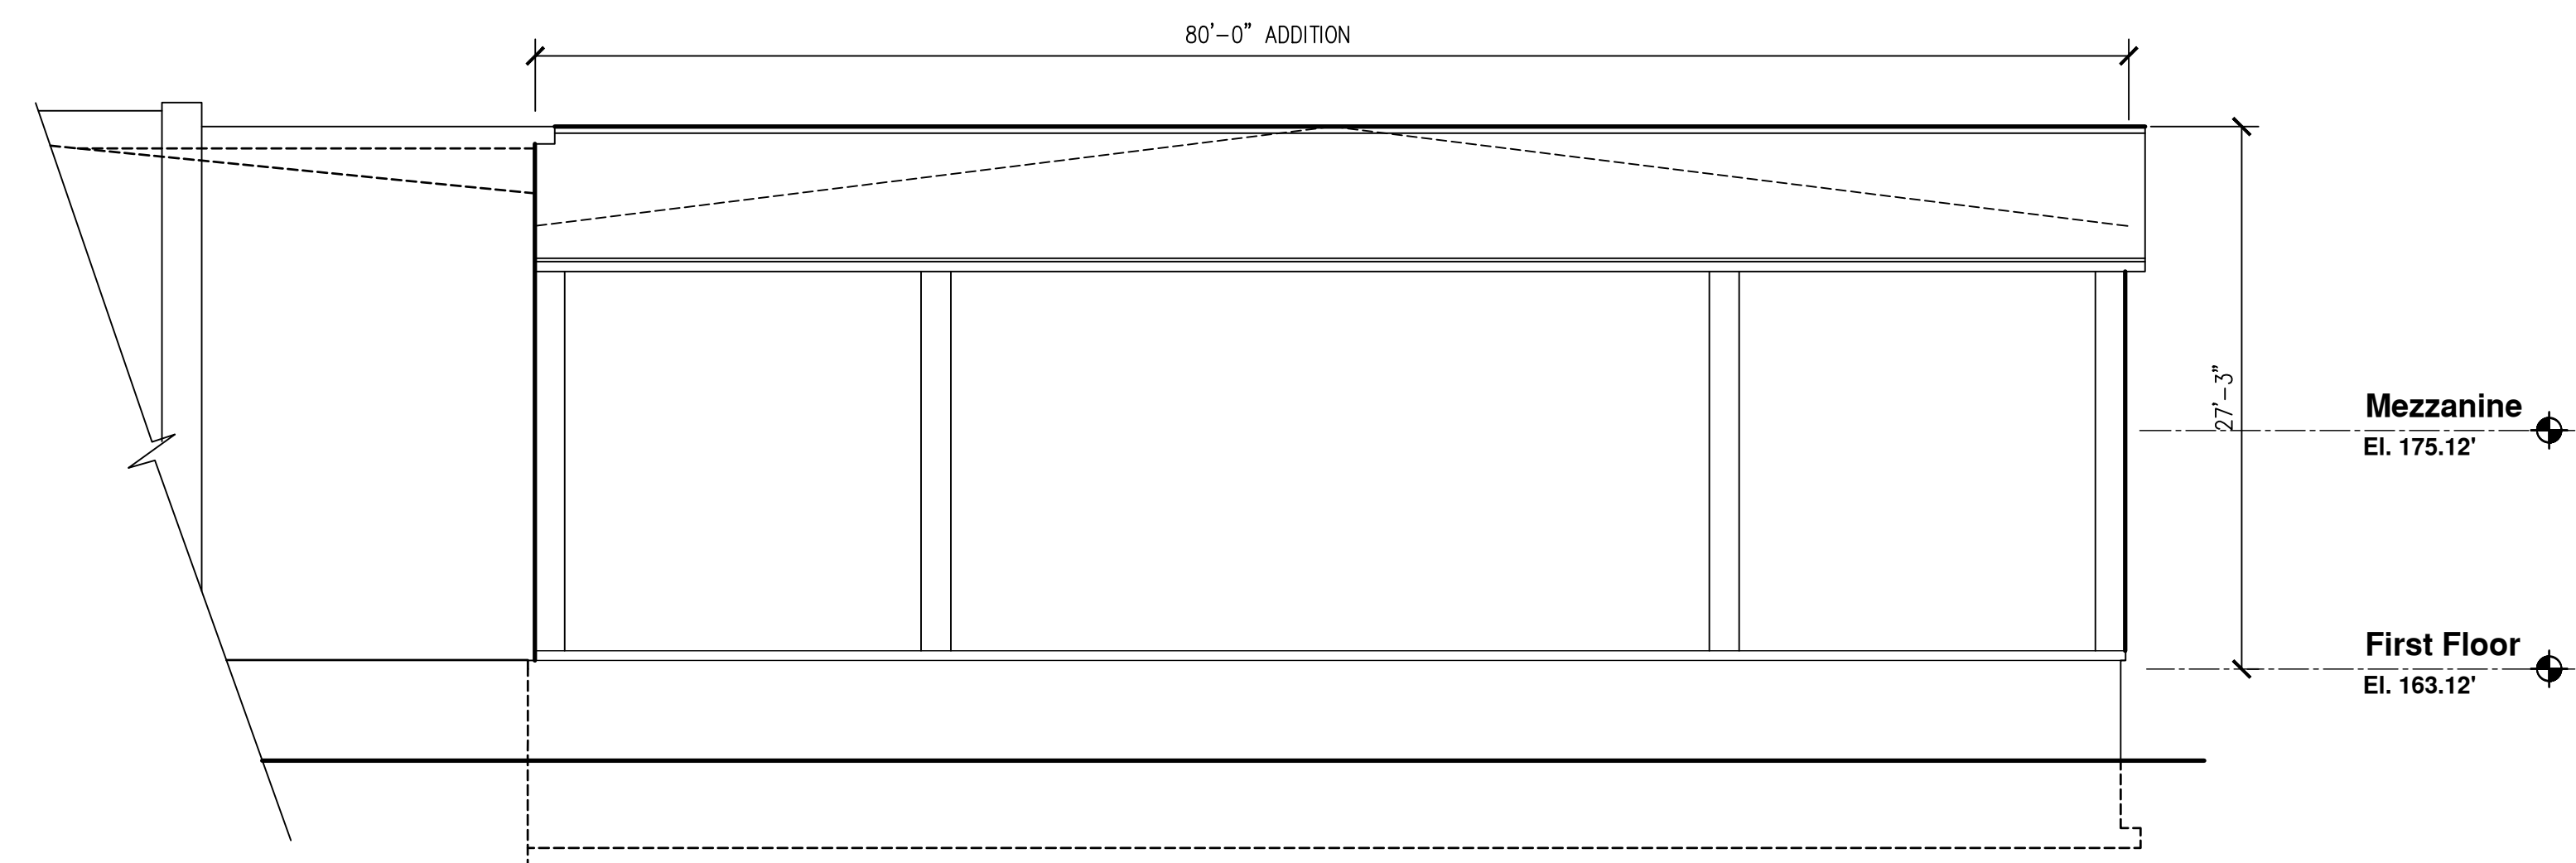

3 Elevation
 SCALE: 1/8" = 1'-0"

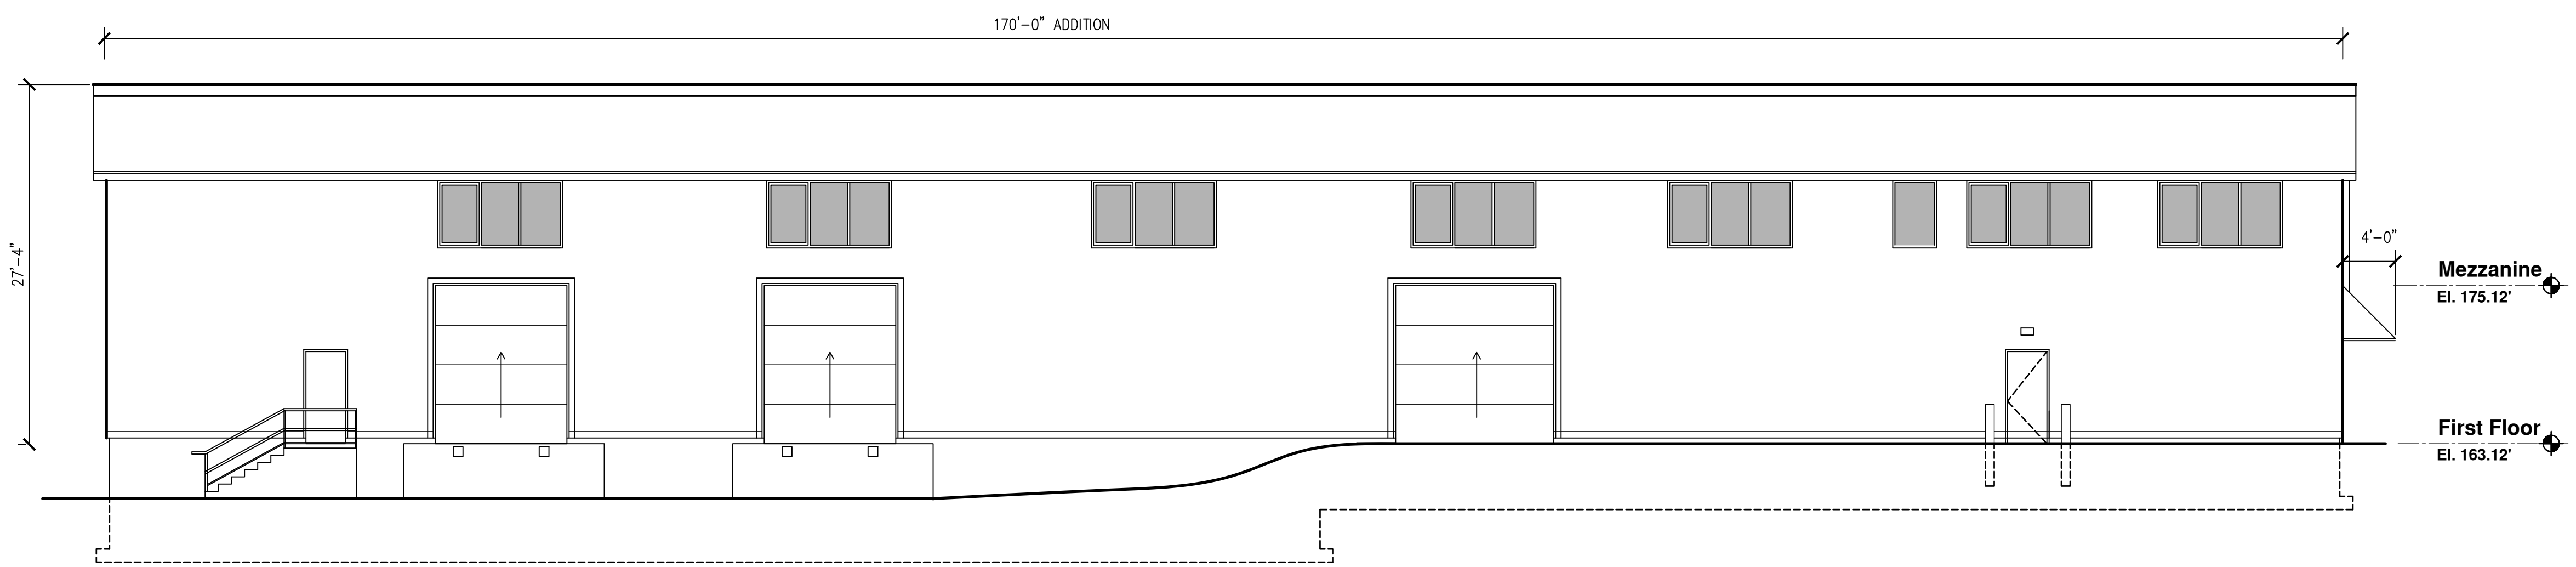

2 Elevation
 SCALE: 1/8" = 1'-0"

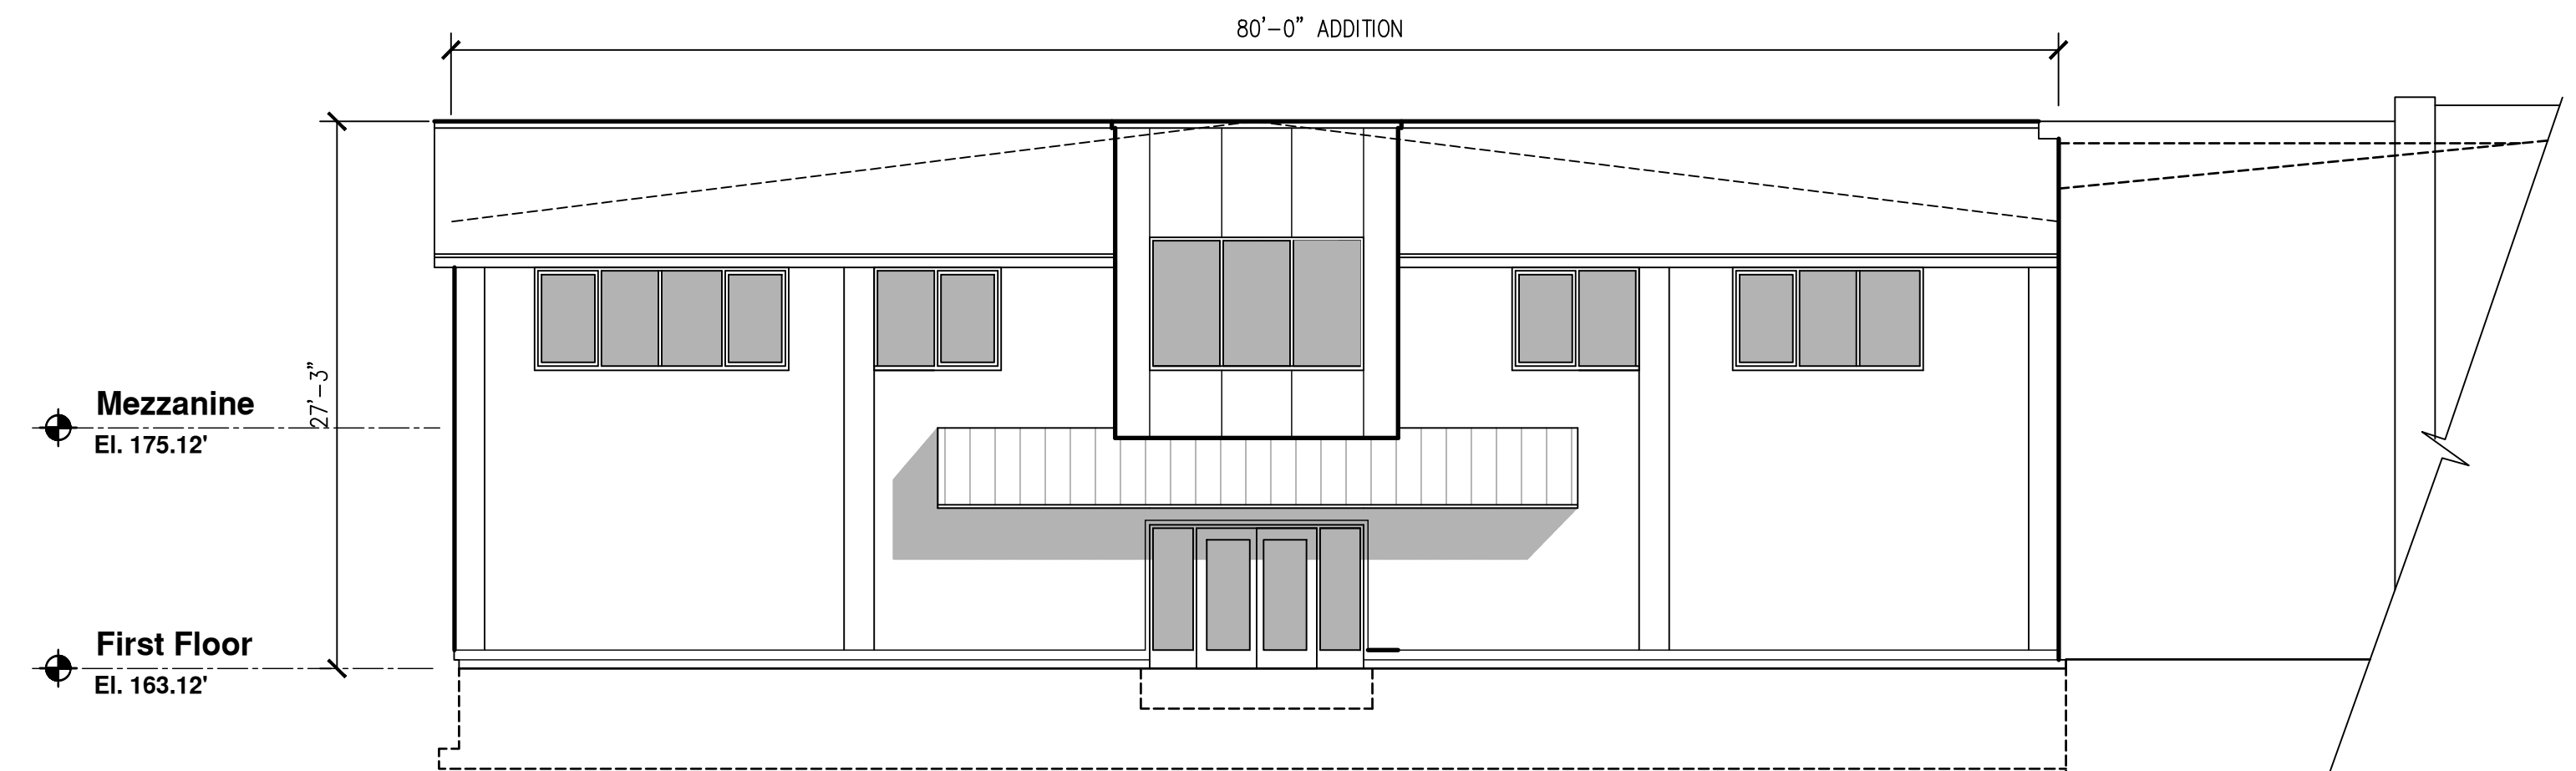

1 Elevation
 SCALE: 1/8" = 1'-0"